


GROUND FLOOR LIGHTING
AND POWER LAYOUT

SCALE 1 : 100

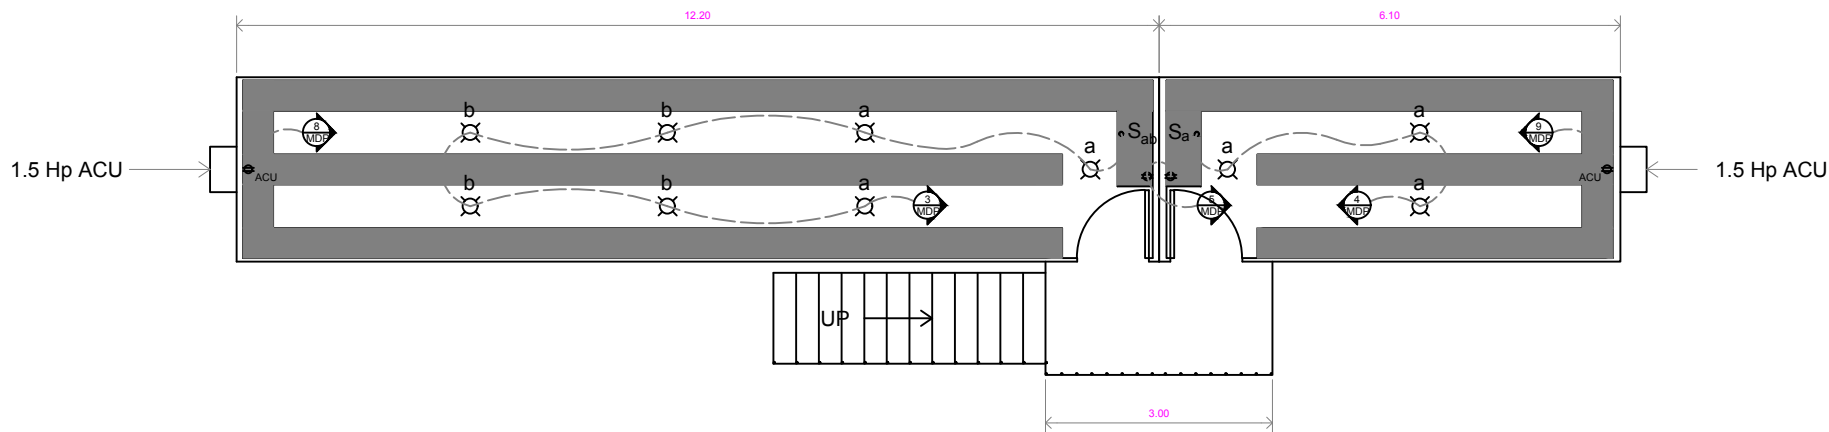

SECOND FLOOR LIGHTING
AND POWER LAYOUT

SCALE 1 : 100